
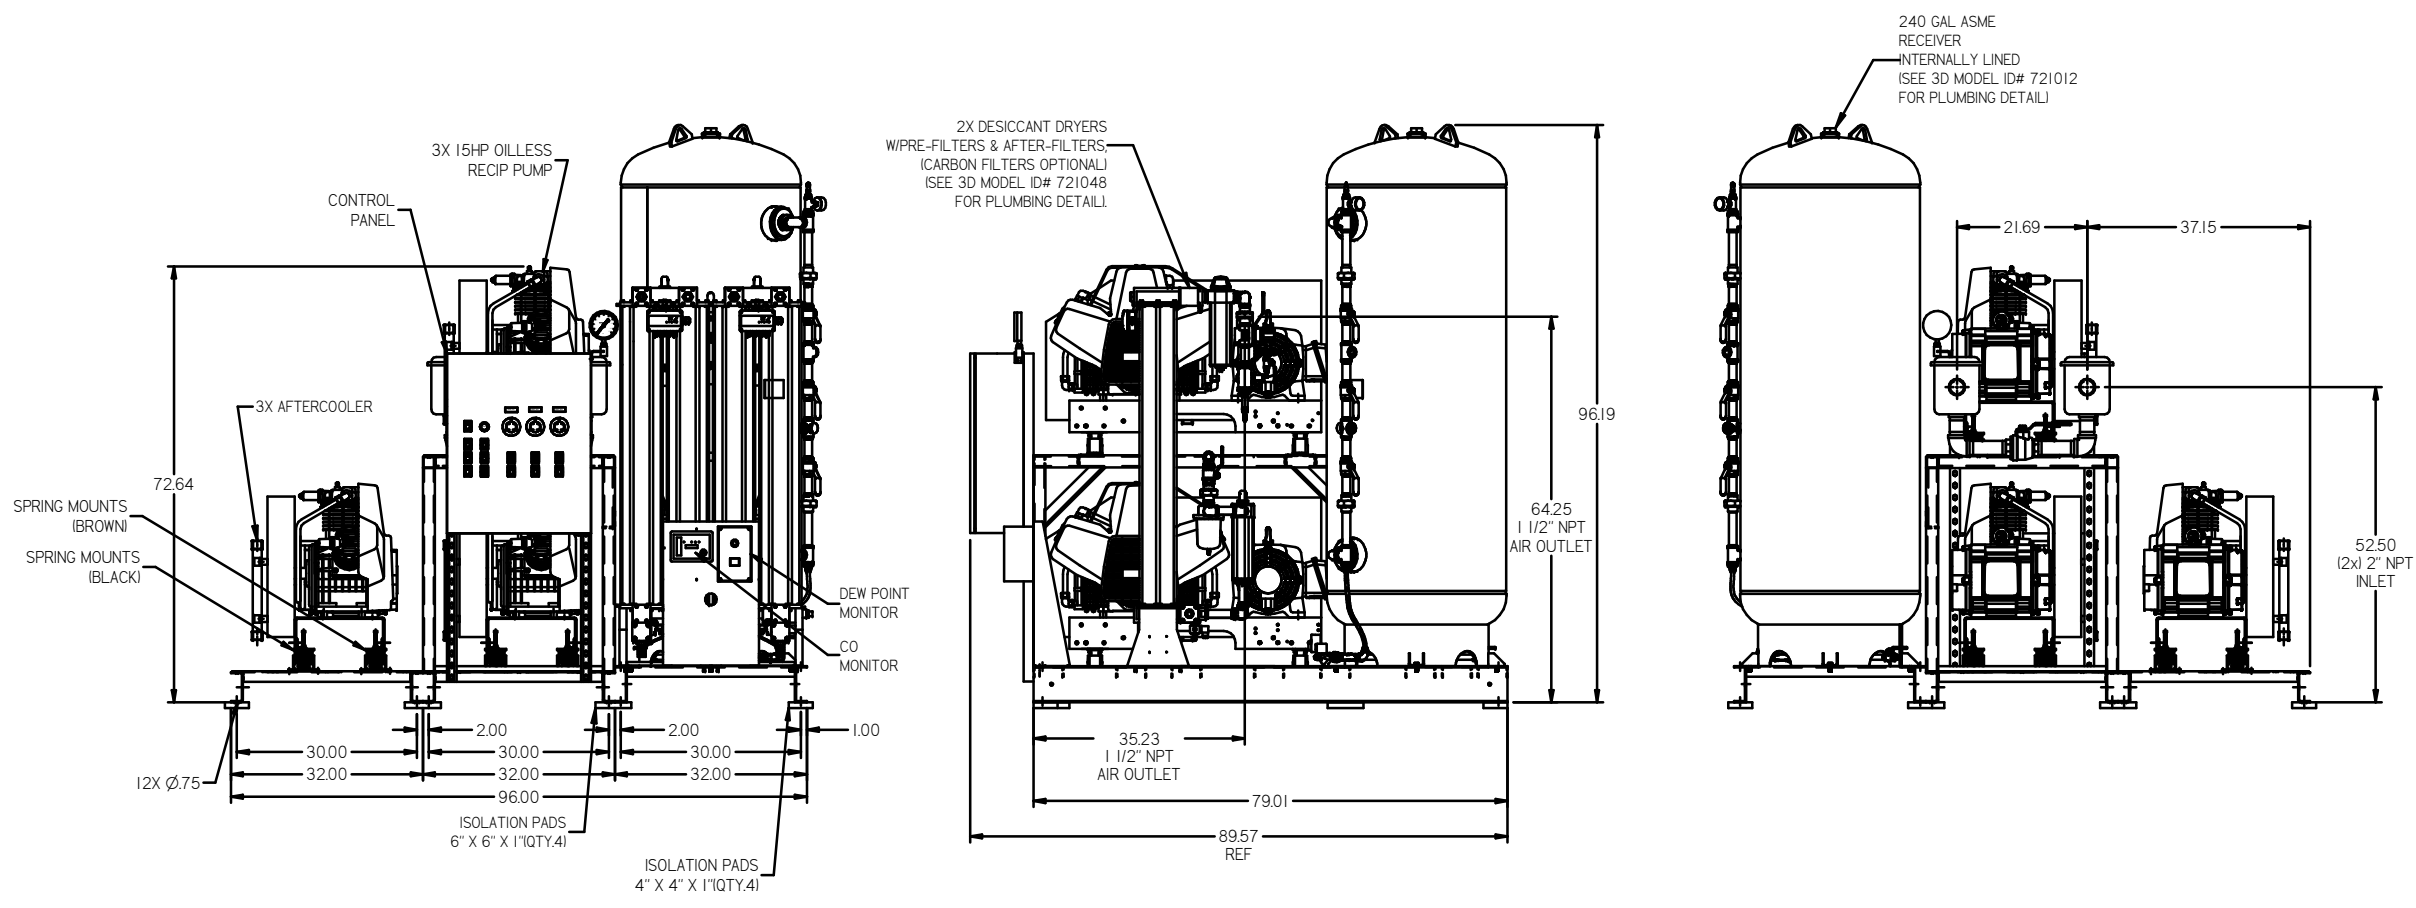


REV	ZONE	REVISION	DATE	ECN	NAME	CHKD
B-1	ALL	RELEASED FOR PRODUCTION	01/12/16		RES	
B-2	3ALL	ADDED COG LOCATIONS PAGE 3	10/06/06	21436	GES	DMS
C-1	2 CA	ADDED MANUAL DRAIN	11/07/07	21699	AEK	GES
D-1	2 ALL	UPDATED FLOW SCHEMATIC	12/30/07	21890	AEK	GES
E-1	D-4	ADDED ISO VALVE, HANG TAG, TANK GAUGE	04/06/08	21907	DMS	GES
F-1	BB-7	ADDED SPRING COLOR LOCATIONS	08/10/08	22039	GES	DMS
G-1	C-2	REVISED DEW POINT MOUNTING	05/29/09	22127	GES	DMS
H-1	1 ALL	REMOVED 11 BASE W/O & RELOCATED PANEL AND DRYERS	02/24/09	22286	AEK	GES
J-1	ALL	CHANGED TO POWERED DRYER	11/41/10	22120	AEK	GES
K-1	1 ALL	UPDATED PUMP FRAMES AND DRYER	02/21/10	22407	AEK	GES
L-1	1 ALL	UPDATED AFTERCOOLER MOUNTING BRACKET	12/31/10	22407	AEK	GES
M-1	ALL	ADDED SHEETS 3 & 4	12/02/10	22348	AEK	AKD
N-1	ALL	ADDED PUMP SHEETS	02/23/11	22609	AEK	GES
P-1	2 ALL	ADDED/UPDATED FLEX LINES ON FLOW	12/21/13	PRE0030	AEK	GES
Q-1	ALL	UPDATED DRYER OUTLET ORIENTATION	04/15	PRE0030	AEK	GES
R-1	2 D4	REMOVED SLUBBER VALVE	02/09/16	PRE0033	MJD	AEK
S	ALL	UPDATED TO TROENT DRYERS, MORGANTON TANK, TEAMCENTER	08/19	PRE0033	GES	MW

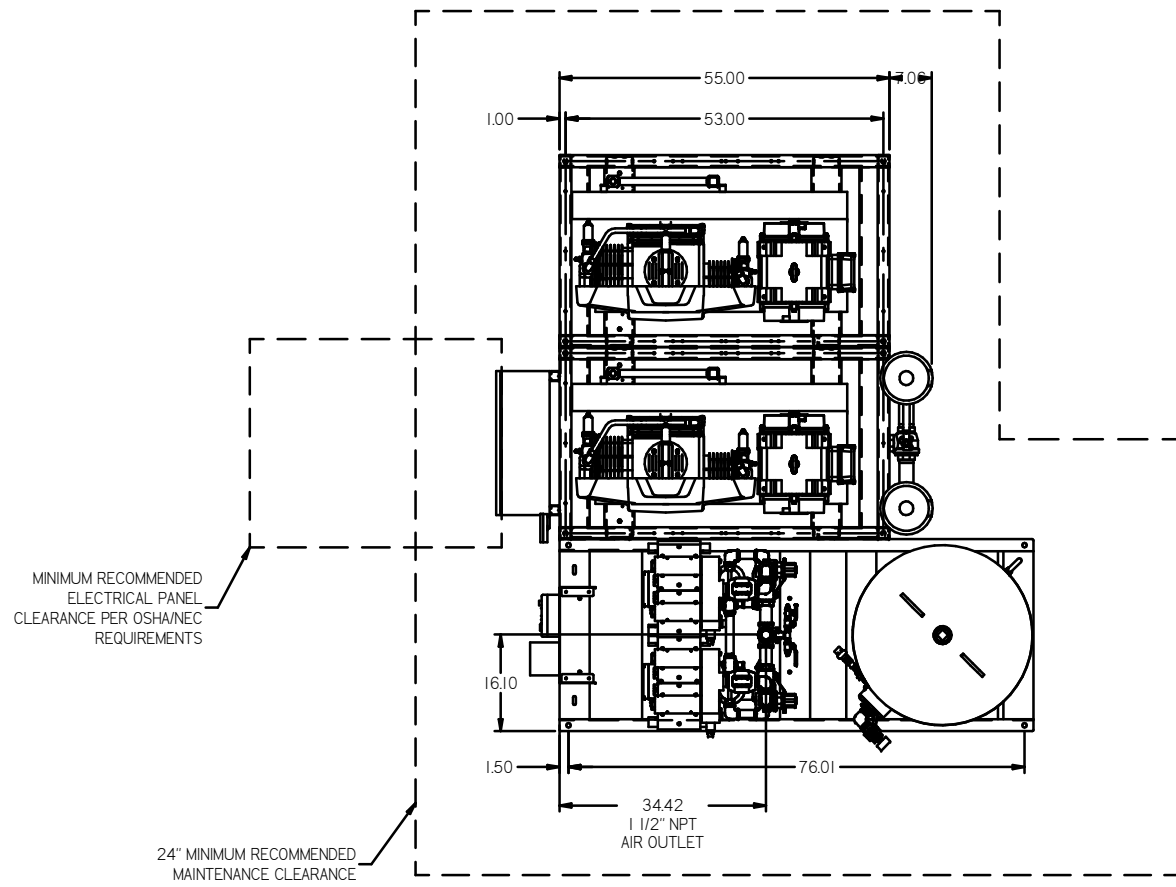

**PROJ. LEGEND**

- ⊖ = MINUS DRAFT
- ⊕ = PLUS DRAFT
- ⊗ = ADDITIONAL CONTROL REQ'D
- ⊘ = BRINELL HARDNESS

TOLERANCES NOT SPECIFIED:  
 XX ±  
 .XX ±  
 .2 (DEG) ±

AUTOCAD REL2000: INCH

DO NOT SCALE DRAWING FOR DIMENSIONS

Sheet 1 of 4 SCALE 1:16

DATE: 04/12/06, 04/21/06, 04/22/06, 07/06/06










APPROVED BY: RSN, GES, DMS, JJJ

**POWEREX**  
 150 PRODUCTION DRIVE, HARRISON, OHIO 45030  
 PH: 800-705-7075 FAX: (513) 363-3100

PART NAME: TRIPLEX OILLESS RECIP.  
 15HP, 240 GAL. BASEMOUNT

DWG NO: MPT1508 SIZE: D

REV	ZONE	REVISION	DATE	EDN	NAME	CHKD
M-1	ALL	ADDED SHEETS 3 & 4	12/20/10	22348	AEK	KMD
M-1	ALL	ADDED P&ID SHEETS	9/23/11	22650	AEK	GES
P-1	2 ALL	ADDED/UPDATED FLEX LINES ON FLOW	12/12/13	P&ID0030	AEK	GES
D-1	ALL	UPDATED DRYER OUTLET ORIENTATION	4/1/15	P&ID0030	AEK	GES
R-1	2 DA	REMOVED SHOWER VALVE	02/09/16	P&ID0033	MJD	AEK
S	ALL	UPDATED TO TROENT DRYERS, MORGANTON TANK, TANK CENTER	6/1/16	P&ID0030	GES	MMH

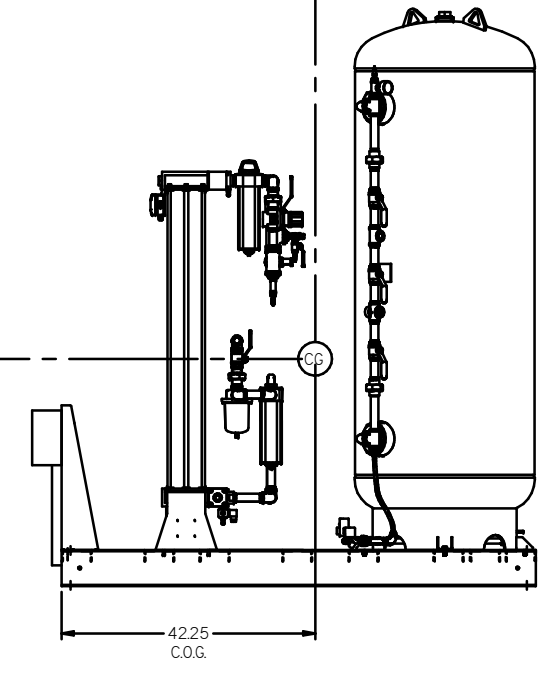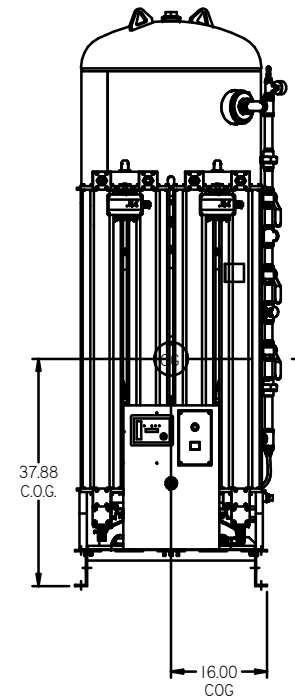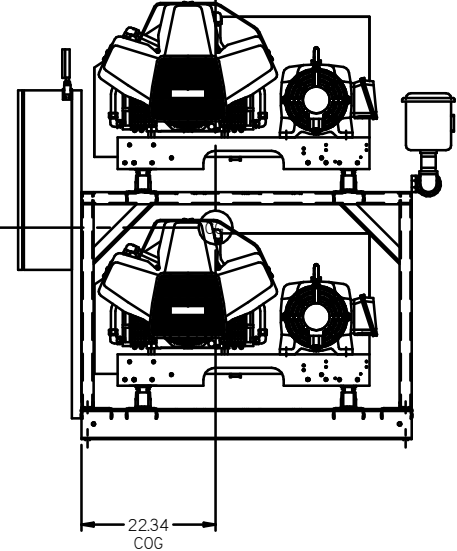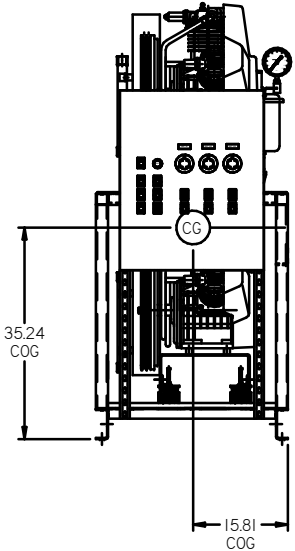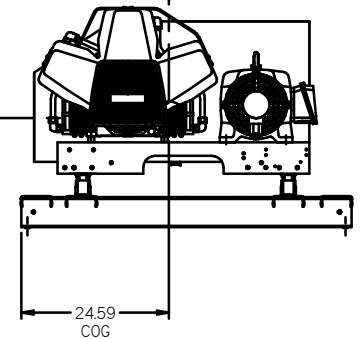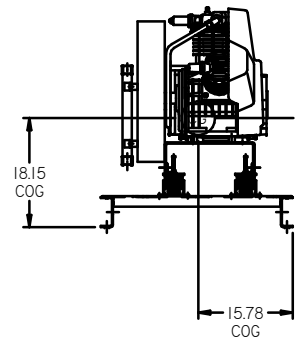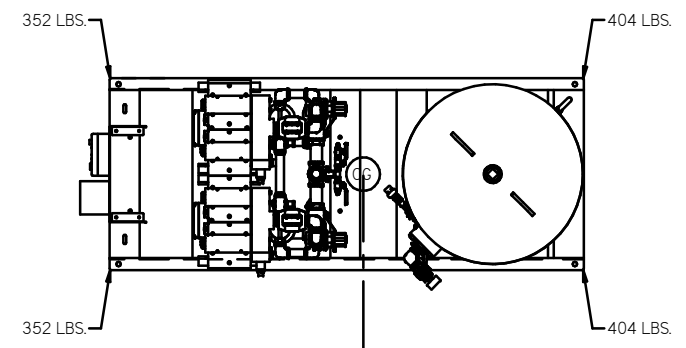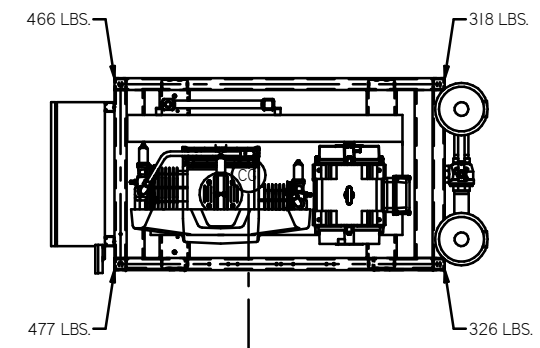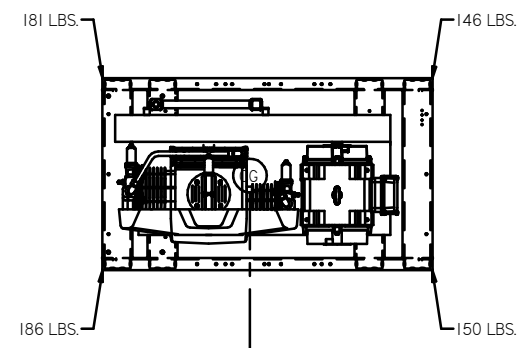

SINGLE PUMP SKID:  
TOTAL WEIGHT: 663 LBS  
C.O.G. DIMENSIONS  
X (FRONT): -15.78"  
Y (RIGHT): 24.59"  
Z (HEIGHT): 18.15"

PANEL/PUMP SKID:  
TOTAL WEIGHT: 1587 LBS  
C.O.G. DIMENSIONS  
X (FRONT): -15.81"  
Y (RIGHT): 22.34"  
Z (HEIGHT): 35.24"

DRYER/TANK SKID:  
TOTAL WEIGHT: 1512 LBS  
C.O.G. DIMENSIONS  
X (FRONT): -16"  
Y (RIGHT): 42.25"  
Z (HEIGHT): 37.87"


CG denotes center of gravity

(MINUS) = MINUS DRAFT (PLUS) = PLUS DRAFT (HARDNESS) = BRINELL HARDNESS	(CONTROL) = ADDITIONAL CONTROL (RED) = RED 'D'	Drawings to conform to the current revision of the following standards: 114.3 (Units) and sectional view dep. 114.5M (Dimensioning and tolerancing)
TOLERANCES NOT SPECIFIED: XX ± .005 XXX ± .010 Z (REG.) ± .015	AUTOCAD REL2008	DO NOT SCALE DRAWING FOR DIMENSIONS
INCH		Sheet 3 of 4
CONFIDENTIAL DISCLOSURE: This drawing is the property of POWEREX, INC. of the SCOTT FETZER COMPANY and subject to return on demand. Its contents are confidential and must not be copied or submitted to outside parties for use or reproduction.		SCALE: 1:16
MATERIAL: N/A	PART NAME: TRIPLEX DILLESS RECIP. 15HP, 240 GAL. BASEMOUNT	DRAWN BY: AEK CHECKED BY: KMD APPROVED BY: KMD, JJ DATES: 12/20/10, 12/26/10, 12/26/10, 12/26/10
DWG NO: MPT1508		SIZE: D





REV	ZONE	REVISION	DATE	ECN	NAME	CHKD
1	ALL	RELEASED FOR PRODUCTION	07/20/05		GES	DMS
B-2	3ALL	ADDED C.O.G. LOCATIONS PAGE 3	10/02/06	21436	GES	DMS
C-1	2 CA	ADDED MANUAL DRAIN	11/07	21689	AEK	GES
D-1	2 ALL	UPDATED FLOW SCHEMATIC	12/3/07	21890	AEK	GES
E-1	D-4	ADDED ISO VALVE, HANG TAG, TANK GAUGE	04/26/08	21907	DMS	GES
F-1	1B-7	ADDED SPRING COLOR LOCATIONS	8/1/08	22039	GES	DMS
G-1	C-2	REVISED DEW POINT MOUNTING	05/28/09	22127	GES	DMS
H-1	1 ALL	REMOVED BASE SH-3 & RELOCATED PANEL AND DRIVERS	9/24/09	22286	AEK	GES
J-1	ALL	CHANGED TO POWEREX DRYER	11/14/10	22120	AEK	GES
K-1	1 ALL	UPDATED PUMP FRAMES AND DRYER	4/22/10	22407	AEK	GES
L-1	1 ALL	UPDATED AFTER-COOLER MOUNTING BRACKET	12/31/10	22407	AEK	GES
M-1	ALL	ADDED SHEETS 3 & 4	12/22/10	22348	AEK	AMD
N-1	ALL	ADDED PBM SHEETS	9/23/11	22809	AEK	GES
P-1	2 ALL	ADDED/UPDATED FLEX LINES ON FLOW	12/13/13	PHEC0030	AEK	GES
Q-1	ALL	UPDATED DRYER OUTLET ORIENTATION	4/15/15	PHEC0100	AEK	GES
R-1	2 04	REMOVED DRAINER VALVE	02/09/16	PHEC0133	AMD	AEK
S	ALL	UPDATED TO TRENCH DRYERS, MORGANTON TANK, TEMPERATURE	8/11/19	PHEC0133	GES	MMH

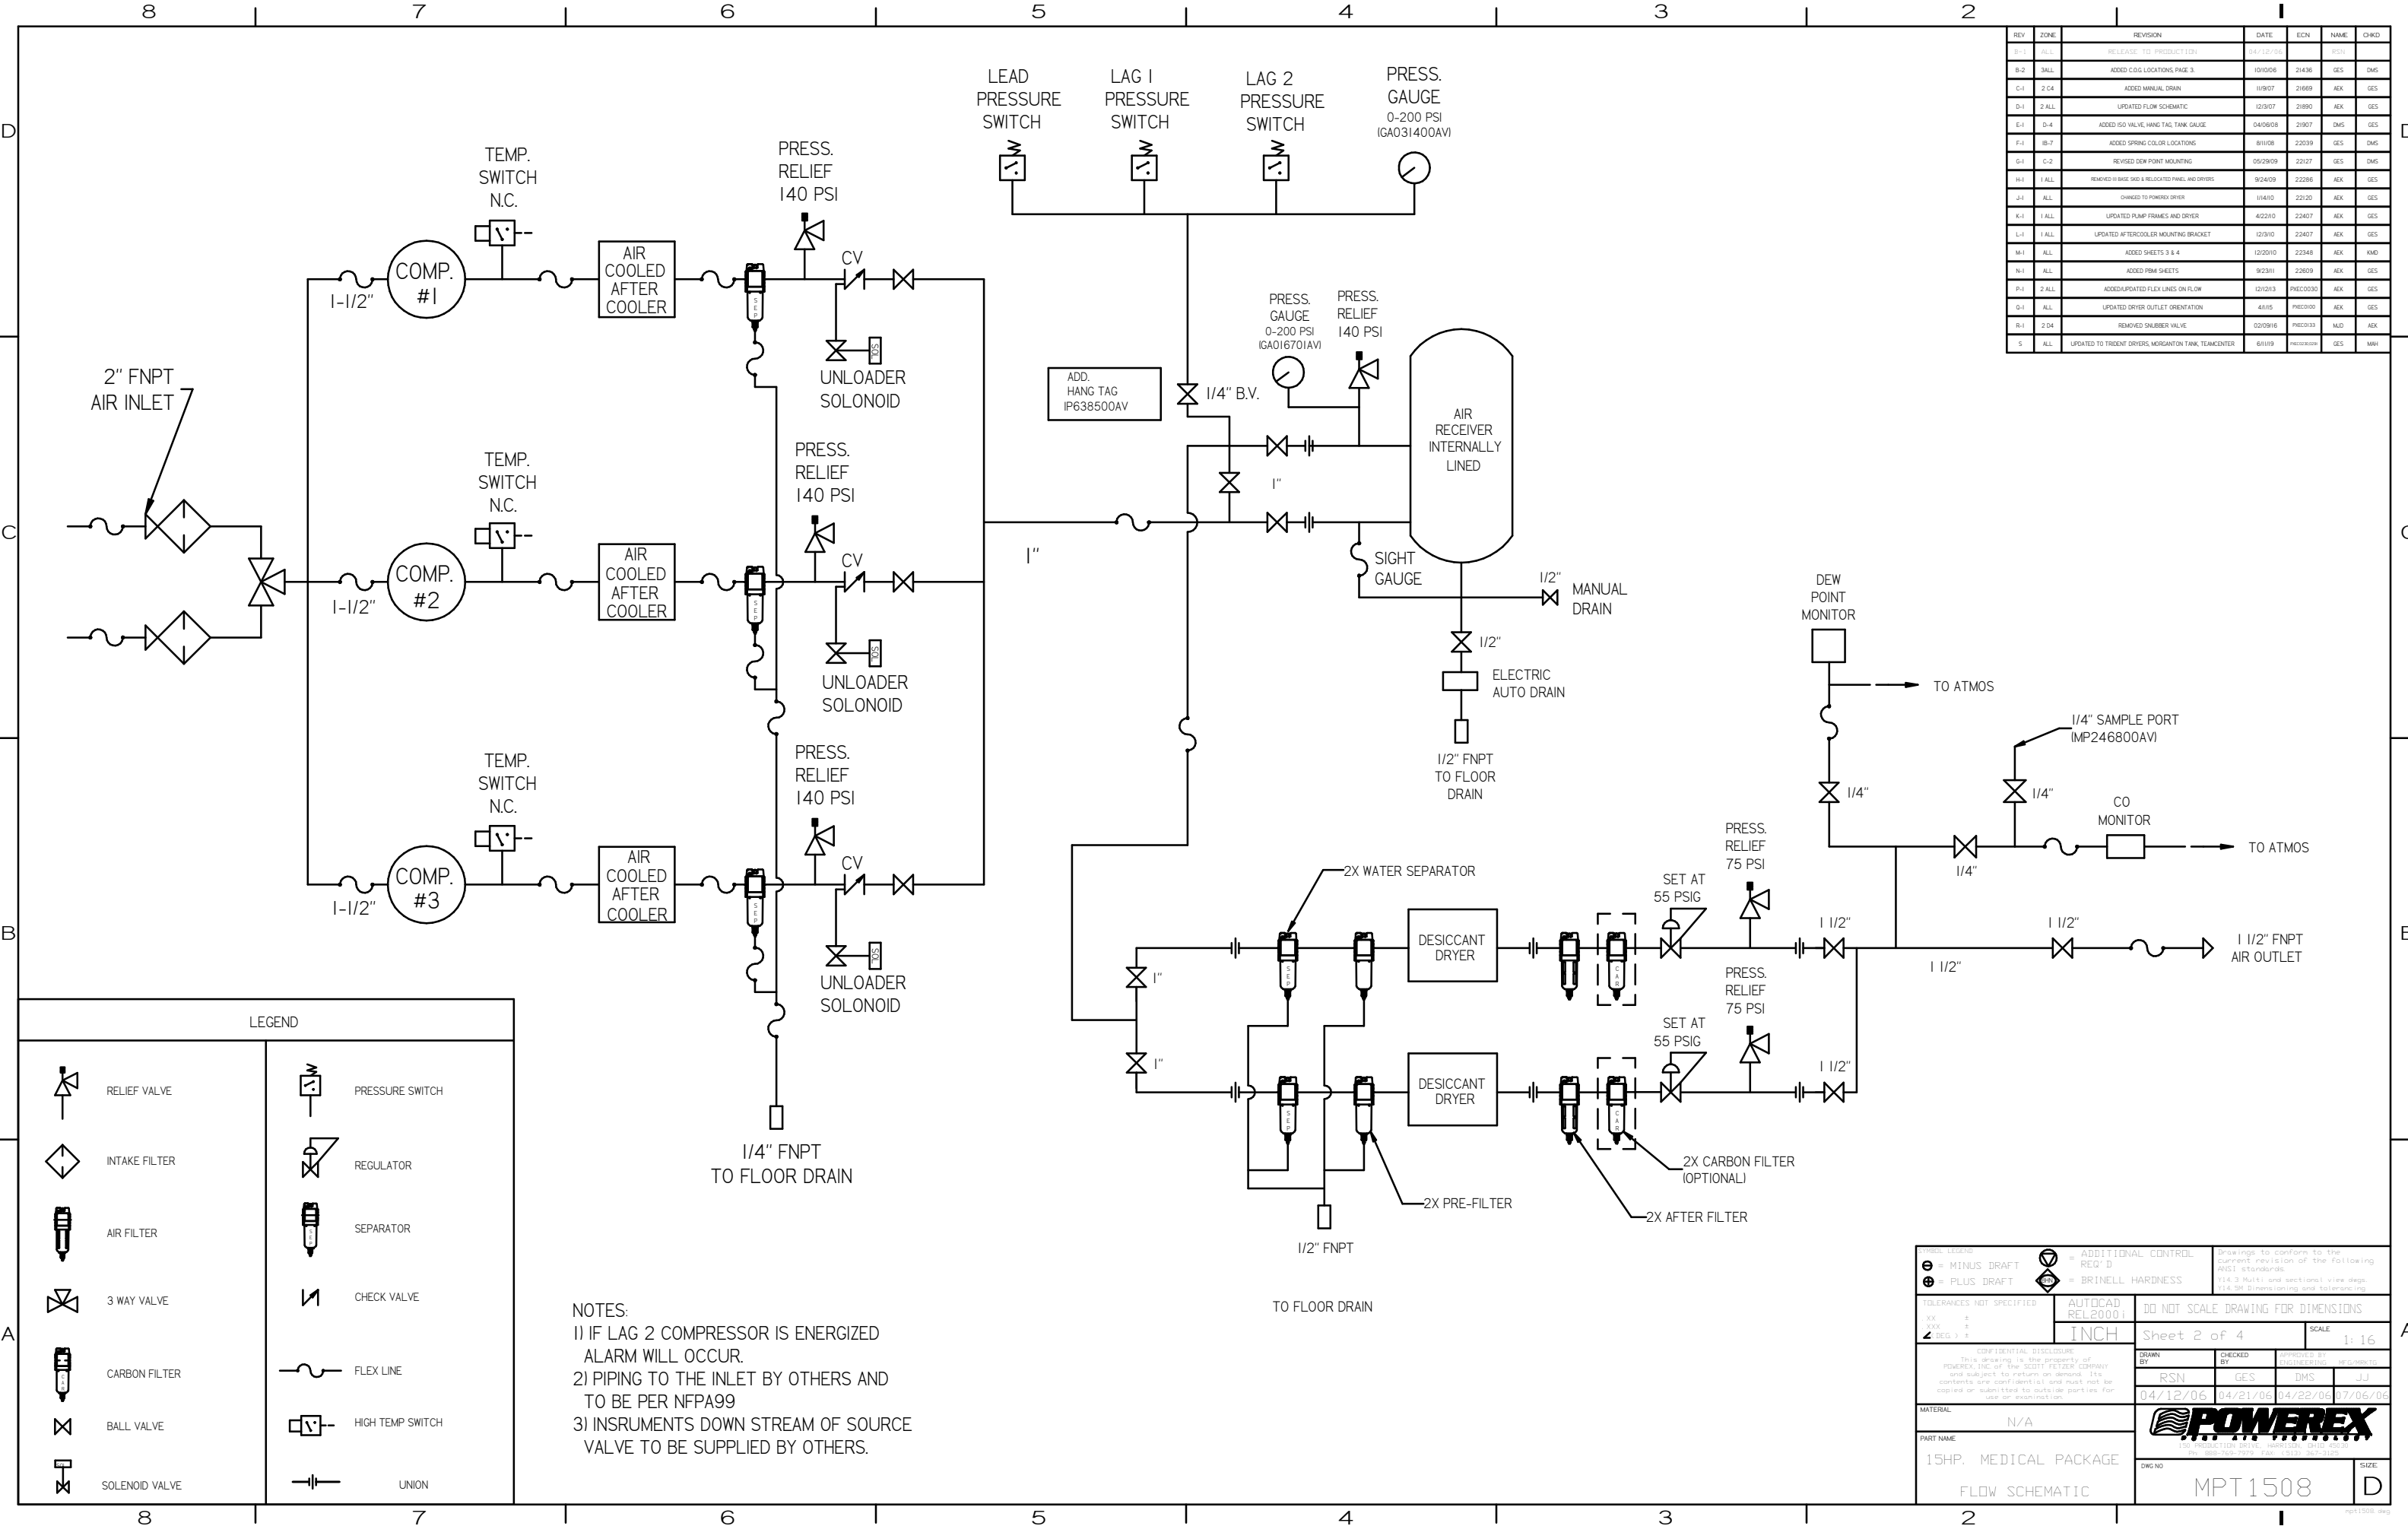





LEGEND

	RELIEF VALVE		PRESSURE SWITCH
	INTAKE FILTER		REGULATOR
	AIR FILTER		SEPARATOR
	3 WAY VALVE		CHECK VALVE
	CARBON FILTER		FLEX LINE
	BALL VALVE		HIGH TEMP SWITCH
	SOLENOID VALVE		UNION

NOTES:  
 1) IF LAG 2 COMPRESSOR IS ENERGIZED ALARM WILL OCCUR.  
 2) PIPING TO THE INLET BY OTHERS AND TO BE PER NFPA99  
 3) INSTRUMENTS DOWN STREAM OF SOURCE VALVE TO BE SUPPLIED BY OTHERS.

SYMBOL LEGEND		= ADDITIONAL CONTROL		Drawings to conform to the current revision of the following ANSI standards.	
= MINUS DRAFT		= BRINELL HARDNESS		1:4 Multi and sectional view steps, 1:4 and 1:8 dimensioning and tolerancing.	
TOLERANCES NOT SPECIFIED		AUTOCAD REL:2000.1		DO NOT SCALE DRAWING FOR DIMENSIONS	
XX ±		INCH		Sheet 2 of 4	
1/2 DEF. ±				SCALE 1:16	
CONFIDENTIAL DISCLOSURE		APPROVED BY		DATE	
This drawing is the property of POWEREX, INC. of the SCOTT FETZER COMPANY and subject to return on demand. Its contents are confidential and must not be copied or submitted to outside parties for use or inspection.		RSN		JUL	
		GES		04/22/06	
		DMS		04/21/06	
				07/06/06	
MATERIAL		N/A			
PART NAME		15HP. MEDICAL PACKAGE		DMS NO	
FLOW SCHEMATIC				MPT1508	
				SIZE D	










REV	ZONE	REVISION	DATE	ECN	NAME	CRD
R-1	ALL	ADDED PBMI SHEETS	9/23/11	102609	AEK	GES
R-2	ALL	ADDED/UPDATED FLEX LINES ON FLOW	10/20/11	1026030	AEK	GES
R-3	ALL	UPDATED DRYER OUTLET ORIENTATION	4/15/12	1026005	AEK	GES
R-4	2/4	REMOVED SLUBBER VALVE	5/20/16	1026033	MJD	AEK
S	ALL	UPDATED TO TRENT DRYERS, MORGANTON TANK, TEAMCENTER	6/1/19	1026033	GES	MW

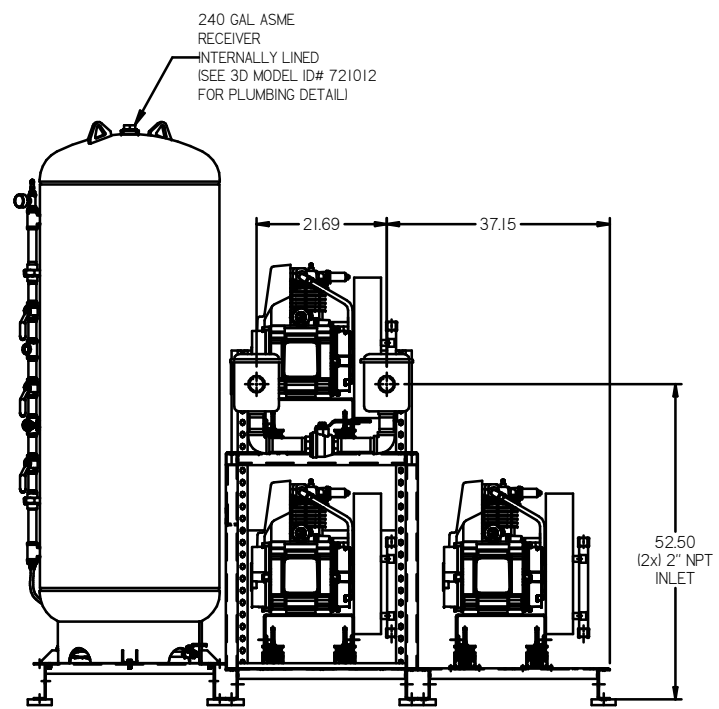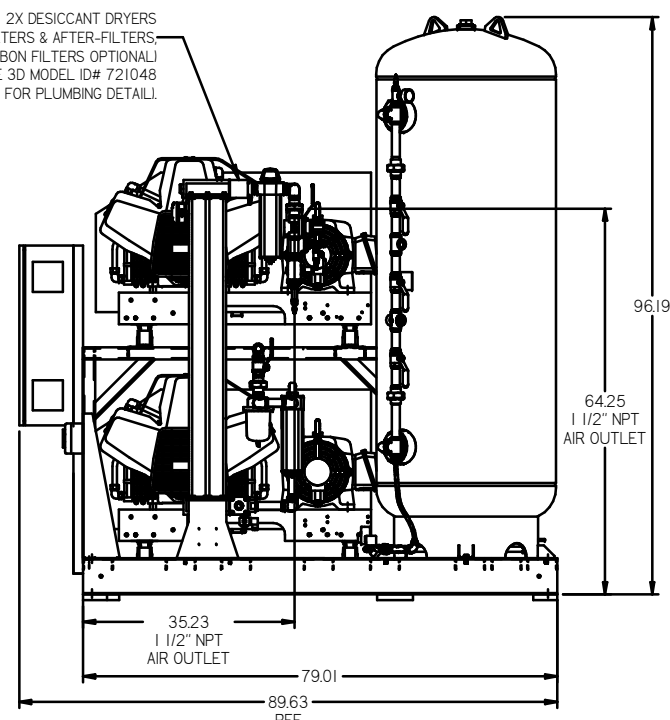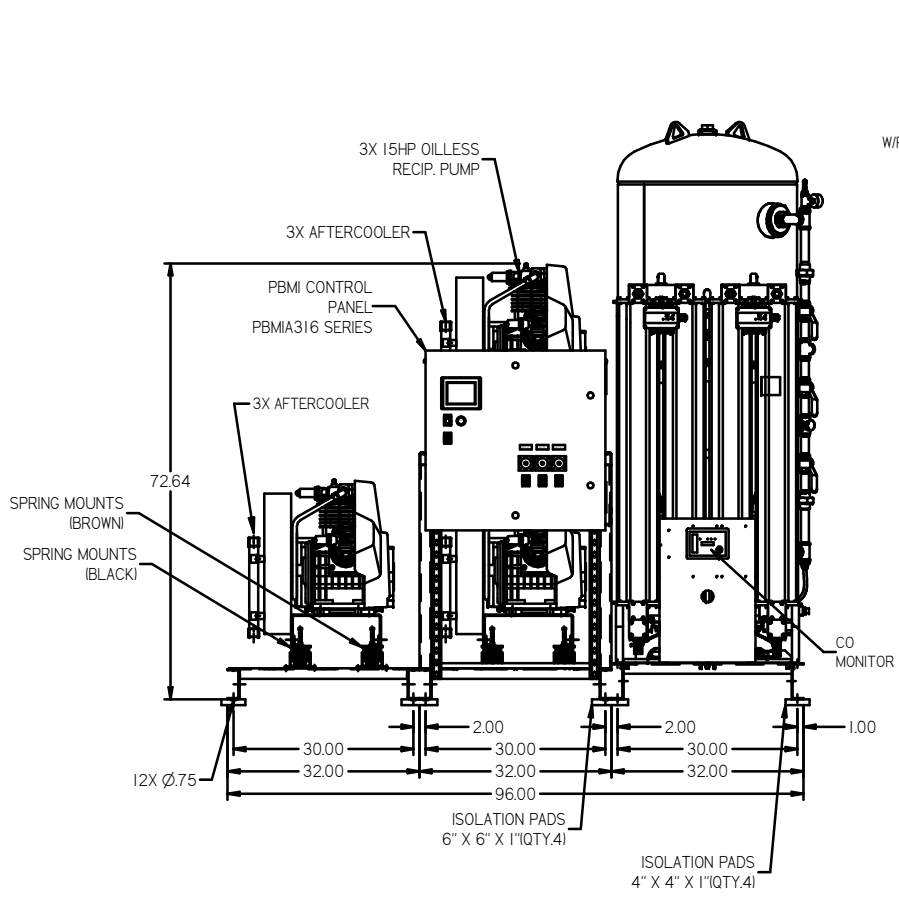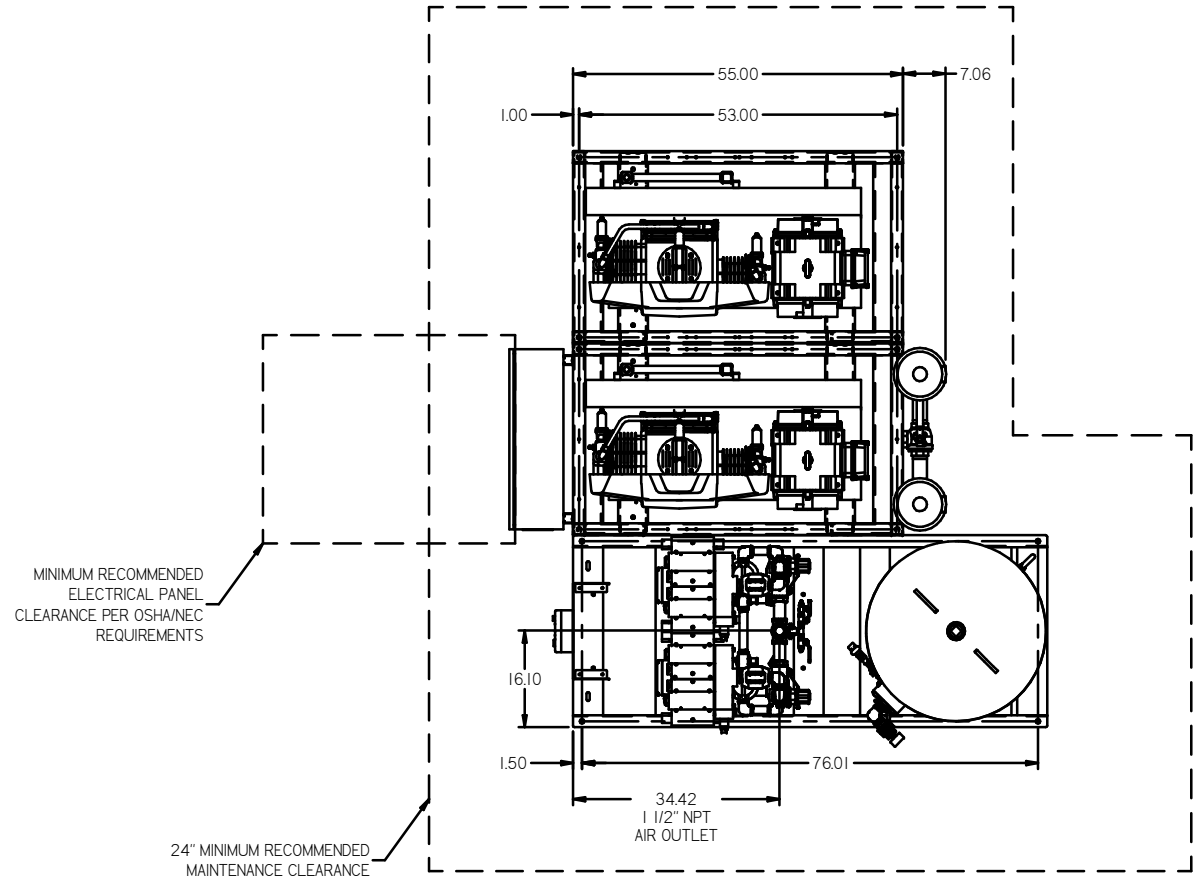

NOTE: SYSTEM DESIGNED IN COMPLIANCE WITH U.S. NFPA '99, LATEST EDITION

TOLERANCES NOT SPECIFIED XX ± .1 XXX ± .05 Z DEC 1-2	AUTOCAD REL2008 LT INCH	DO NOT SCALE DRAWING FOR DIMENSIONS Sheet 1 of 4 SCALE 1:16
CONFIDENTIAL DISCLOSURE This drawing is the property of POWEREX, INC. of the SCOTT FETZER COMPANY and subject to return on demand. Its contents are confidential and must not be copied or submitted to outside parties for use or reproduction.		DRAWN BY: AEK CHECKED BY: GES APPROVED BY: DMS, RJR 9/23/11, 9/23/11, 9/23/11, 9/23/11
MATERIAL: N/A PART NAME: TRIPLEX OILLESS RECIP. 15HP, 240 GAL. BASEMOUNT		 MPT1508 SIZE: D

REV	ZONE	REVISION	DATE	ECN	NAME	CHKD
1	ALL	ADDED PBM1 SHEETS	9/23/11	27657	AEK	GES
2	ALL	ADDED/UPDATED FLEX LINES ON FLOW	12/12/10	PRE0030	AEK	GES
3	ALL	UPDATED DRYER OUTLET ORIENTATION	4/1/10	PRE0030	AEK	GES
4	2/04	REMOVED GUNBER VALVE	02/09/10	PRE0033	MJD	AEK
5	ALL	UPDATED TO TRODENT DRYERS, MORGANTON TANK TEAMCENTER	01/19/10	PRE0030	GES	MW

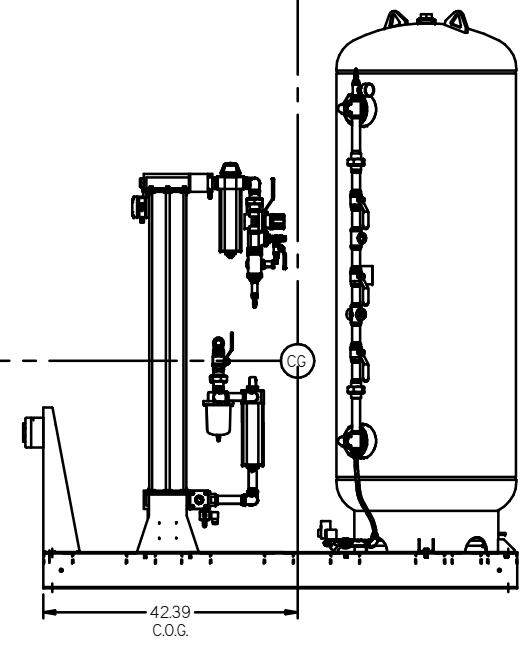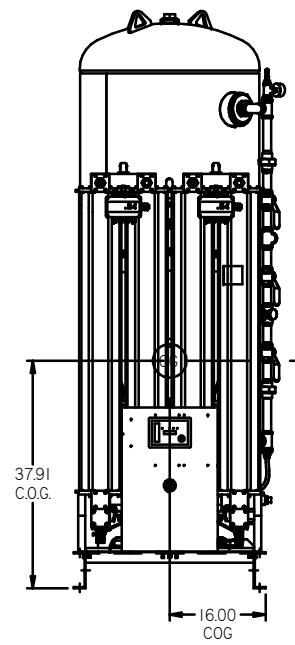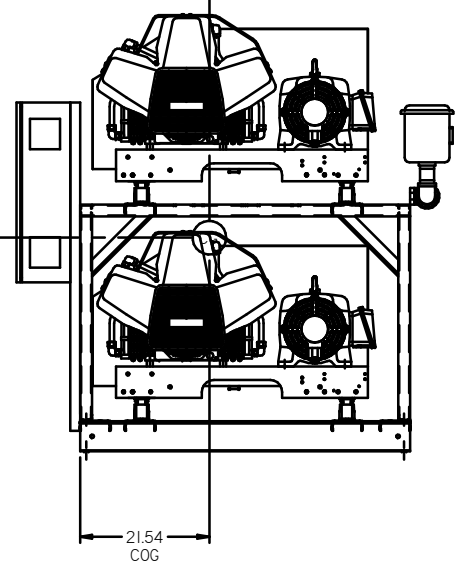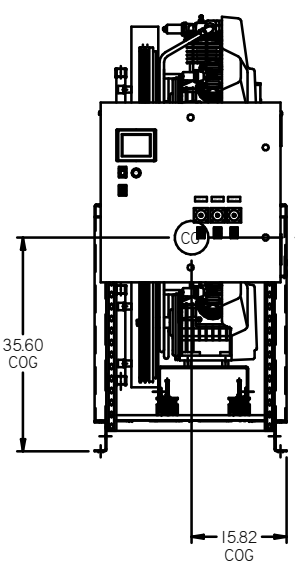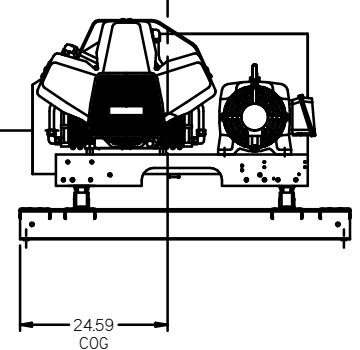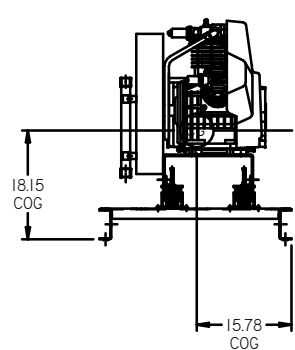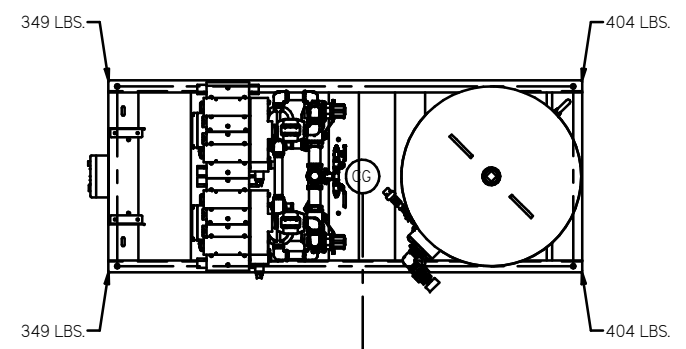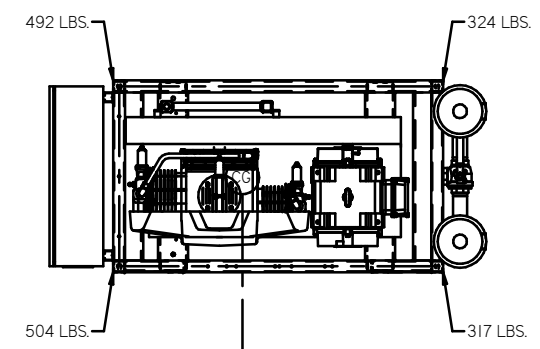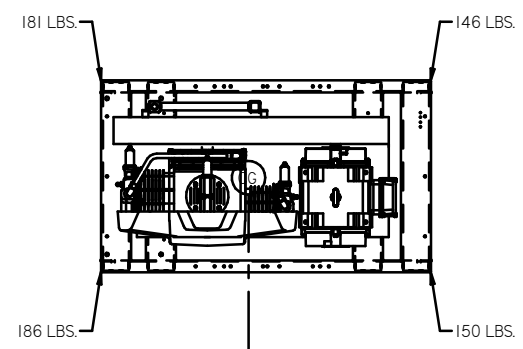

SINGLE PUMP SKID:  
TOTAL WEIGHT: 663 LBS  
C.O.G. DIMENSIONS  
X (FRONT): -15.78"  
Y (RIGHT): 24.59"  
Z (HEIGHT): 18.15"

PANEL/PUMP SKID:  
TOTAL WEIGHT: 1637 LBS  
C.O.G. DIMENSIONS  
X (FRONT): -15.81"  
Y (RIGHT): 21.54"  
Z (HEIGHT): 35.60"

DRYER/TANK SKID:  
TOTAL WEIGHT: 1507 LBS  
C.O.G. DIMENSIONS  
X (FRONT): -16"  
Y (RIGHT): 42.39"  
Z (HEIGHT): 37.91"



CG denotes center of gravity

MINUS DRAFT PLUS DRAFT TOLERANCES NOT SPECIFIED XX REG. 1-5	ADDITIONAL CONTROL REQ'D BRINELL HARDNESS	drawings to conform to the current revision of the following ANSI standards: (A.3 Multi) and sectional view steps (A.8) Dimensioning and tolerancing
AUTOCAD REL2008 LT INCH Sheet 3 of 4 SCALE 1:16	DO NOT SCALE DRAWING FOR DIMENSIONS	
CONFIDENTIAL DISCLOSURE This drawing is the property of POWEREX, INC. of the SCOTT FEYER COMPANY and subject to return on demand. Its contents are confidential and must not be copied or submitted to outside parties for use or reproduction.		
DRAWN BY: AEK CHECKED BY: GES 9/23/11	DESIGNED BY: DMS 9/23/11	APPROVED BY: RJR 9/23/11
MATERIAL: N/A PART NAME: TRIPLEX DILLESS RECIP. 15HP, 240 GAL. BASEMOUNT		
DWG NO: MPT1508 SIZE: D		

8 7 6 5 4 3 2 1

REV	ZONE	REVISION	DATE	ECN	NAME	CHWD
0-1	ALL	ADDED PINK SHEETS	07/23/11	00001	AEK	GES
1-1	ALL	ADDED/UPDATED FLEX LINES ON FLOW	12/12/13	PRC0000	AEK	GES
2-1	ALL	UPDATED DRIVER OUTLET ORIENTATION	4/1/15	PRC0000	AEK	GES
3-1	2 D4	REMOVED SLUBBER VALVE	02/09/16	PRC0000	MJD	AEK
4	ALL	UPDATED TO TRIDENT DRIVER MORGANTON TANK TEAMCENTER	8/18/19		GES	MW

D  
C  
B  
A

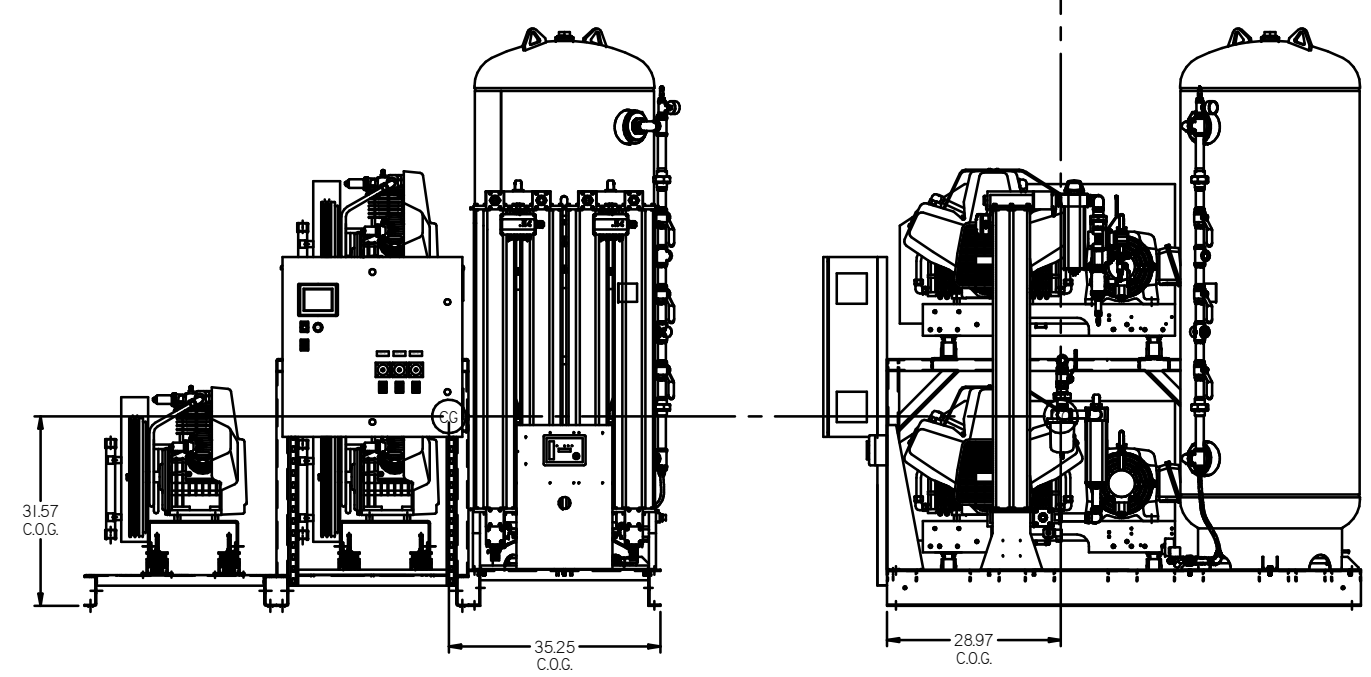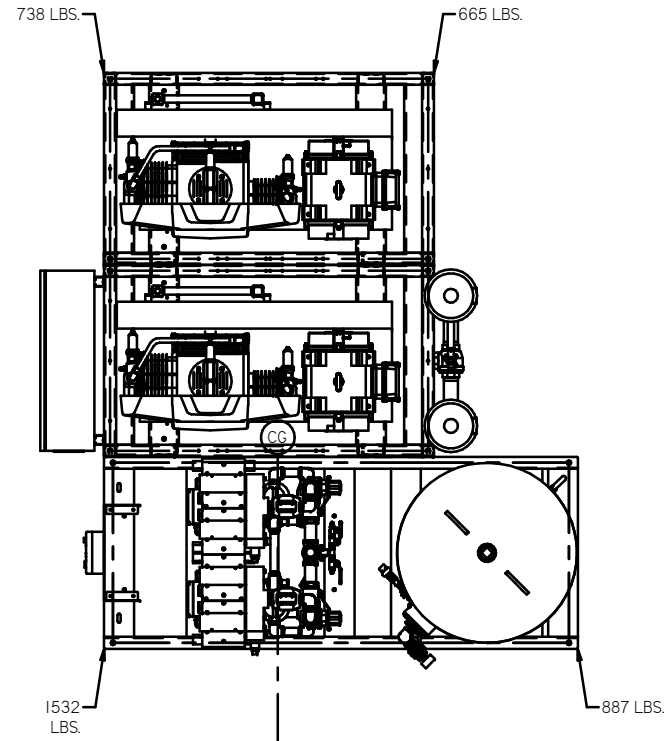


SYSTEM  
 TOTAL WEIGHT: 3822 LBS  
 C.O.G. DIMENSIONS  
 X (FRONT): -35.25"  
 Y (RIGHT): 28.97"  
 Z (HEIGHT): 31.57"

CG denotes center of gravity

SYMBOL LEGEND: ⊖ = MINUS DRAFT ⊕ = PLUS DRAFT ⊕ = ADDITIONAL CONTROL REQ'D ⊕ = BRINELL HARDNESS		Drawings to conform to the current revision of the following ANSI standards: Y14.3 Multi and sectional view dgs. Y14.5 Dimensioning and tolerancing	
TOLERANCES NOT SPECIFIED: XX ± .001 XXX ± .002 XXXX ± .005		AUTOCAD REL2009 LT INCH DO NOT SCALE DRAWING FOR DIMENSIONS Sheet 4 of 4 SCALE 1:16	
CONFIDENTIAL DISCLOSURE This drawing is the property of POWEREX, Inc. of the SCOTT FELTZER COMPANY and subject to return on demand. Its contents are confidential and must not be copied or submitted to outside parties for use or examination.		DRAWN BY: AEK CHECKED BY: GES APPROVED BY: DMS, RJR 9/23/11, 9/23/11, 9/23/11, 9/23/11	
MATERIAL: N/A		PART NAME: TRIPLEX DILLESS RECIP. 15HP, 240 GAL. BASEMOUNT	
DWG NO: MPT1508		SIZE: D	

8 7 6 5 4 3 2 1

REV	ZONE	REVISION	DATE	ECN	NAME	CHKD
1	ALL	ASSEMBLY SHEETS	02/20/11		AEK	GES
2	ALL	ADDED/UPDATED FLEX LINES ON FLOW	12/12/13		AEK	GES
3	ALL	UPDATED DRIVER OUTLET ORIENTATION	4/15		AEK	GES
4	2 D4	REMOVED SLUBBER VALVE	02/09/16		MJD	AEK
5	ALL	UPDATED TO PRESENT ORDER: MORGANTON TANK, TEAMCENTER	6/18/19		GES	MJH

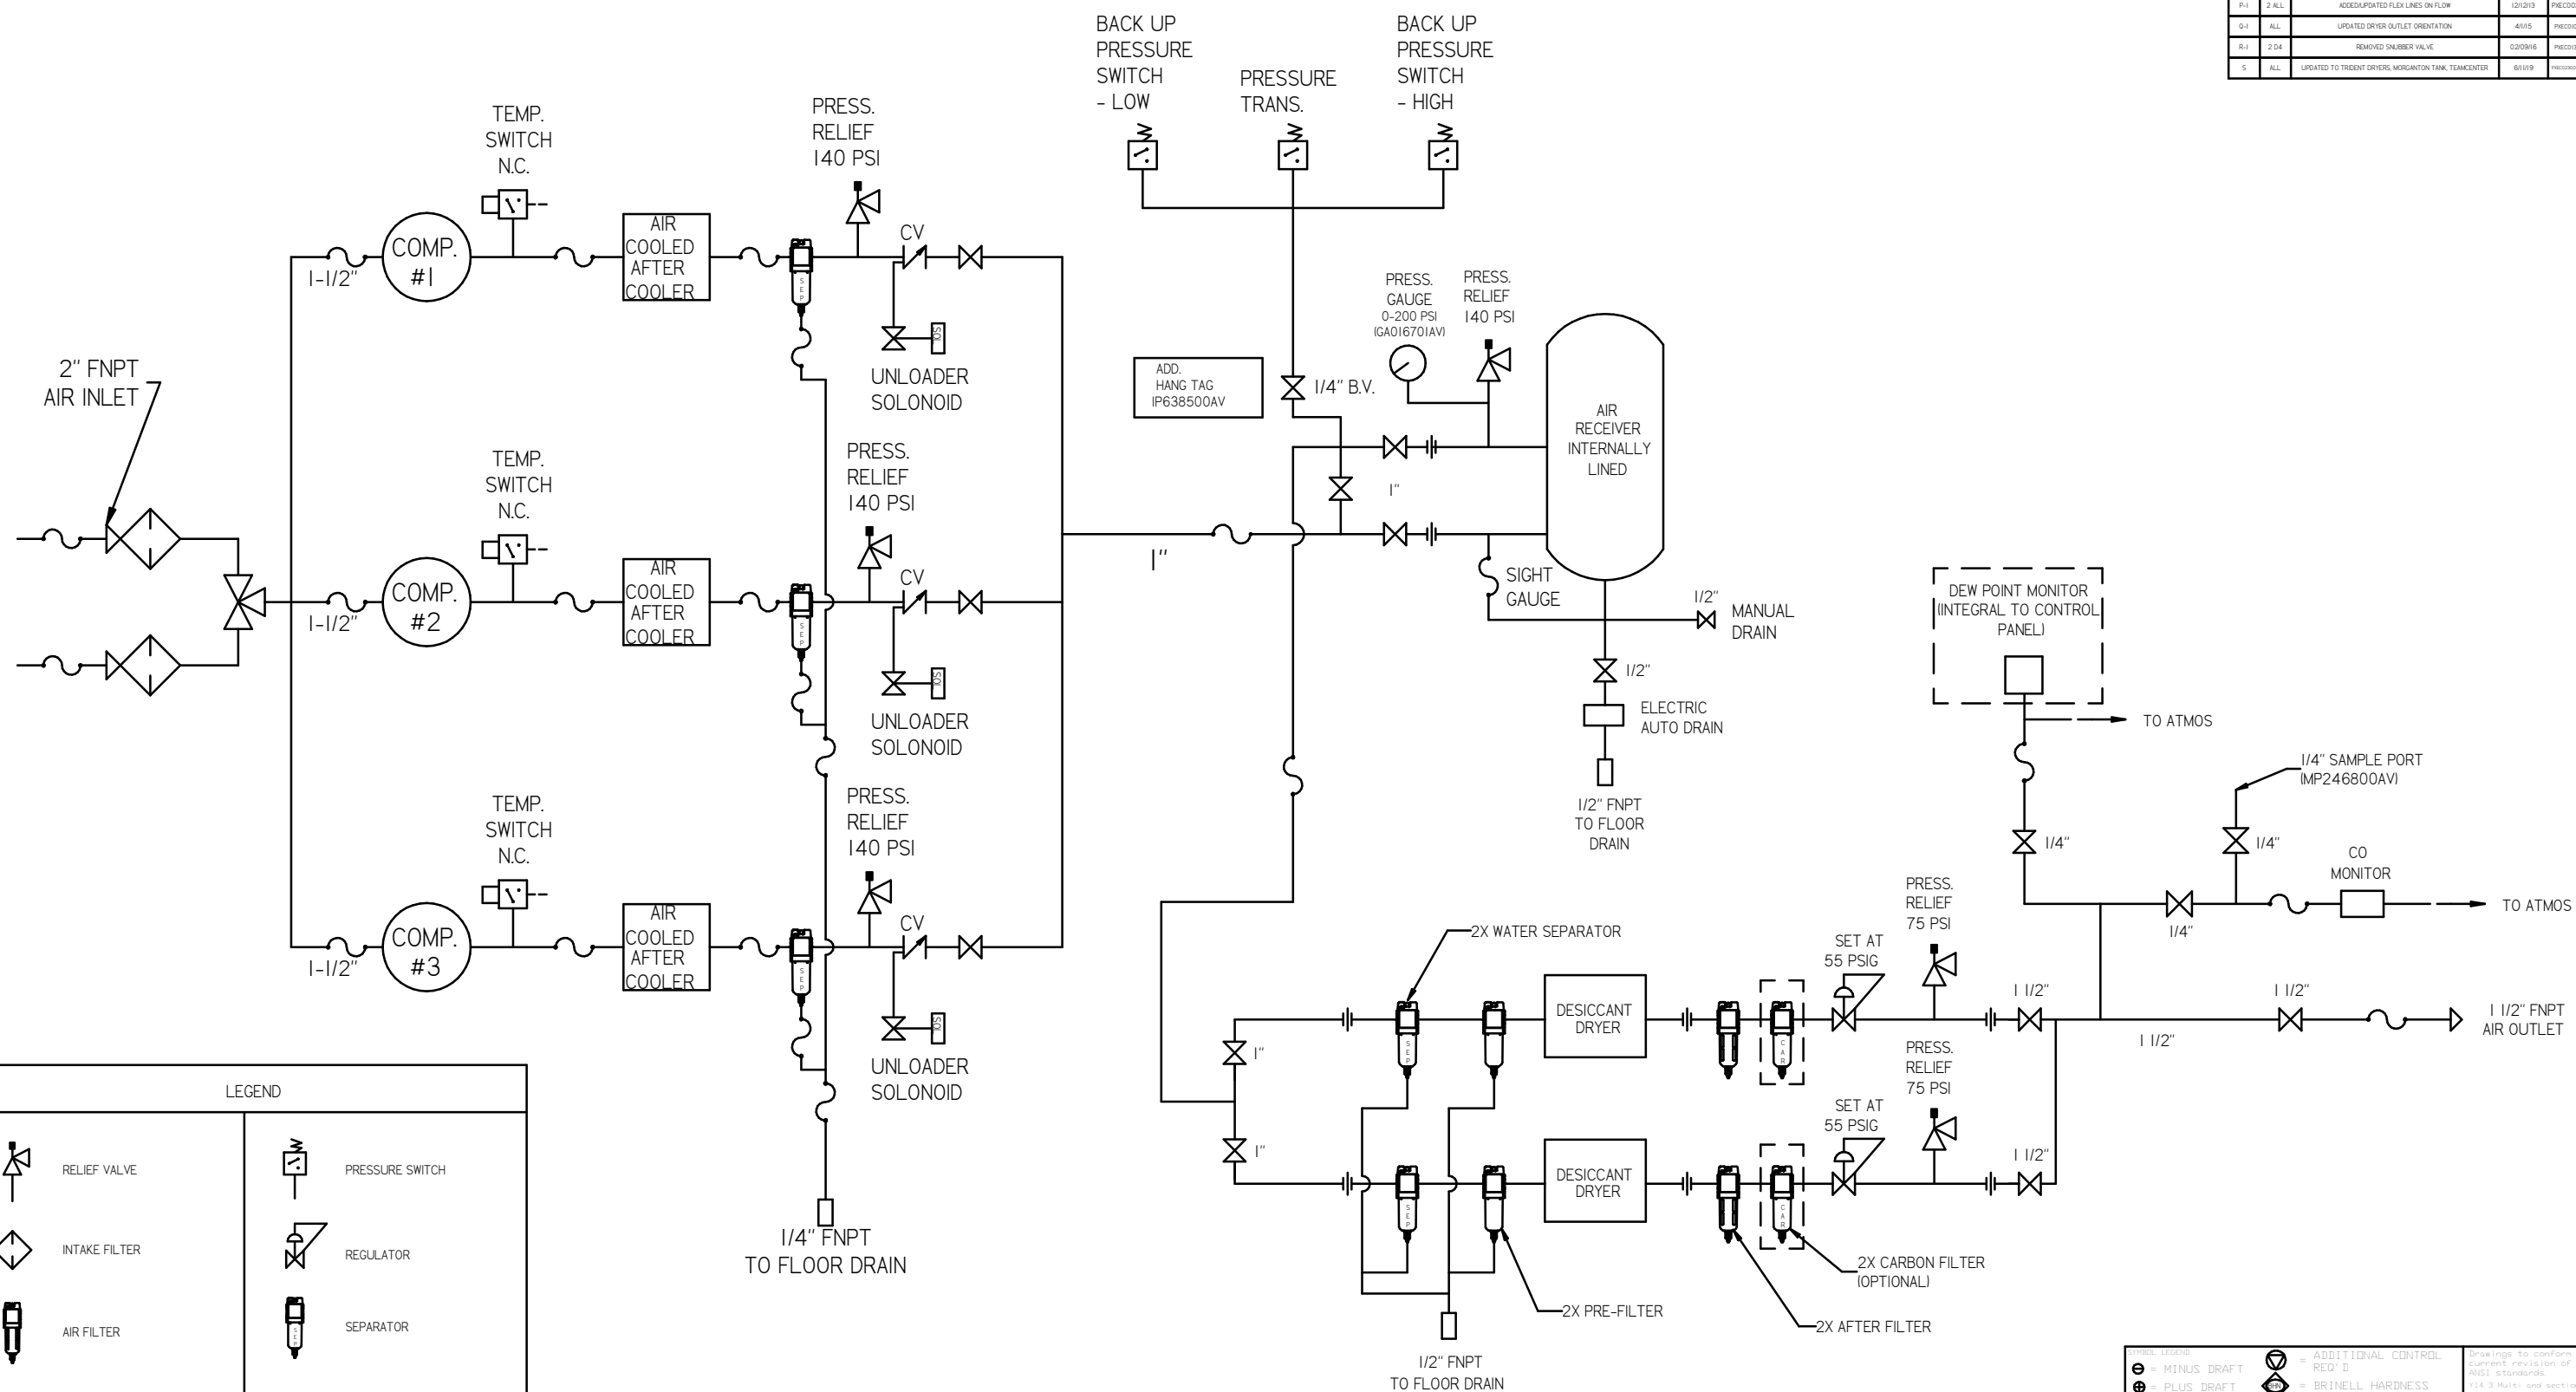

LEGEND

	RELIEF VALVE		PRESSURE SWITCH
	INTAKE FILTER		REGULATOR
	AIR FILTER		SEPARATOR
	3 WAY VALVE		CHECK VALVE
	CARBON FILTER		FLEX LINE
	BALL VALVE		HIGH TEMP SWITCH
	SOLENOID VALVE		UNION

NOTES:  
 1) IF LAG 2 COMPRESSOR IS ENERGIZED ALARM WILL OCCUR.  
 2) PIPING TO THE INLET BY OTHERS AND TO BE PER NFPA99  
 3) INSTRUMENTS DOWN STREAM OF SOURCE VALVE TO BE SUPPLIED BY OTHERS.

<p>SYMBOL LEGEND</p> <p>⊖ = MINUS DRAFT          ⊕ = PLUS DRAFT</p> <p>TOLERANCES NOT SPECIFIED:          .XX ± .005          .XX ± .010          .XX ± .015</p>	<p>⊕ = ADDITIONAL CONTROL REQ'D          ⊖ = BRINELL HARDNESS</p> <p>AUTOCAD RELEASE 1.1          INCH</p> <p>DO NOT SCALE DRAWING FOR DIMENSIONS</p> <p>Sheet 2 of 4          SCALE 1:16</p>	<p>Drawings to conform to the current revision of the following ANSI standards:          Y14.3 Multi and sectional view dgs.          Y14.99 Dimensioning and tolerancing</p>
<p>CONFIDENTIAL DISCLOSURE: This drawing is the property of POWEREX, INC. or the SCOTT FETZER COMPANY and subject to return on demand. The contents are confidential and must not be copied or submitted to outside parties for use or reproduction.</p>	<p>APPROVED BY: [Signature]</p> <p>DATE: 9/23/11</p>	<p>DATE: 9/23/11</p>
<p>MATERIAL: N/A</p> <p>PART NAME: 15HP. MEDICAL PACKAGE</p> <p>FLOW SCHEMATIC</p>	<p>POWEREX          150 PRODUCTION DRIVE, HARRISON, MISSISSIPPI 39042          TEL: 601-422-7274 FAX: 601-422-7425</p>	<p>SIZE: D</p>